


Array Behavioral Care

240 W BROUGHTON ST SAVANNAH GA 31401

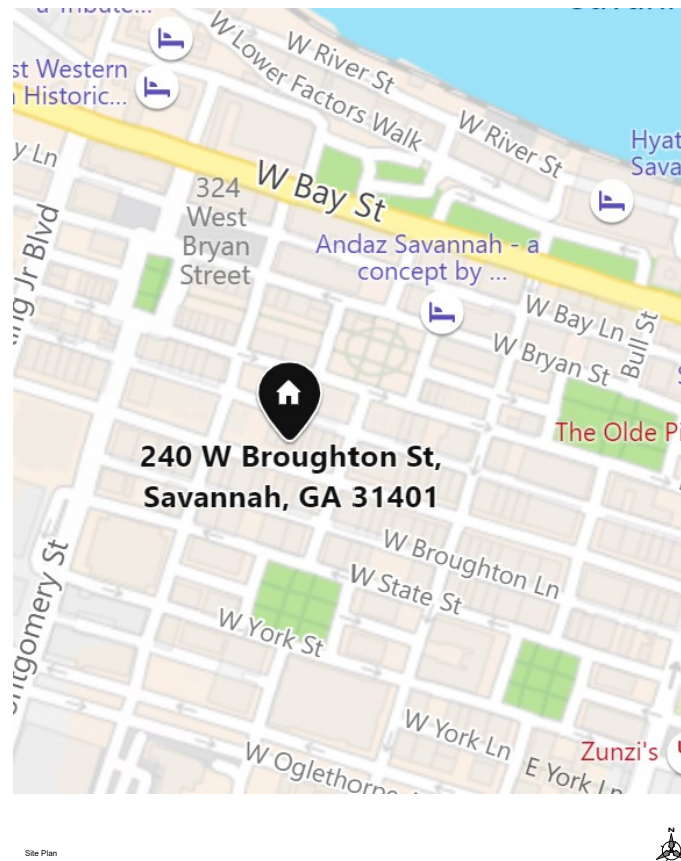

Site Plan

Legend		Sheet List	
		Sheet Name	Sheet Number
	North Arrow	Coversheet	G001
	Section Marker	Life Safety Plan	G101
	Room Name	Floor Plan Third Floor	A101
	Room Tag	Floor Plan Fourth Floor	A102
	ADA Circle	RCP (third floor)	A103
	ADA square	RCP (fourth floor)	A104
		Furniture Plan (third floor)	I101
		Furniture Plan (fourth floor)	I102
		Building Section	A301
		Floor Finish Plan (third floor)	I103
		Floor Finish Plan (fourth floor)	I104
		Large Scale Finish Plan	M01
		Large Scale Power and Data Plan	M02
		Large Scale Furniture Plan with specifications	M03
		Wall Elevations	G01
		Milwork Details	I501

McKenzie Kaeser

McKenzie Kaeser
mkaeser20@student.scsd.edu

Project :
Array Behavioral Care
Project Location :
240 West Broughton St,
Savannah Georgia, 31401




Studio 3


Coversheet

Project Number	Project Number
Date	Issue Date
Drawn By	Author
Checked By	Checker
G001	
Scale	

2/25/2021 7:26:10 PM

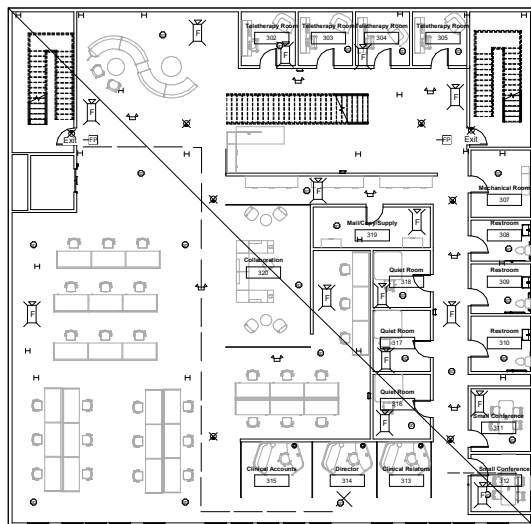

① Third Floor Life Safety
1/8" = 1'-0"

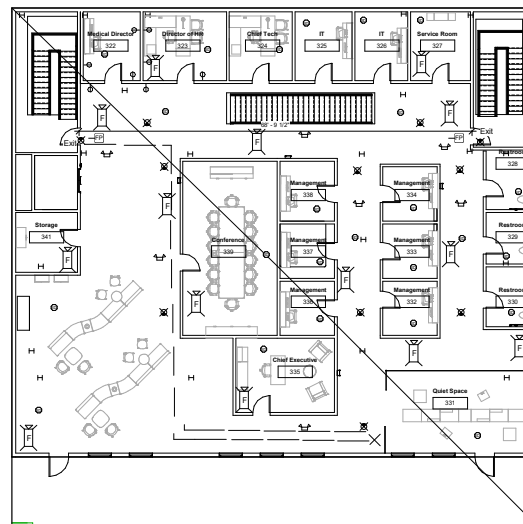

② Fourth Floor Life Safety
1/8" = 1'-0"

Occupancy Load	Means of Egress	Plumbing Fixture Count	Applicable Codes	Legend
Type Business - 150 Load Factor Third Floor 54 People 8077 sq. ft. Fourth Floor 47 People 6967 sq. ft.	Third and Fourth Floor Both Floor Diagonal : 128' 0" Exit Separation on Both Floors : 68' 9" Third Floor Common Path of Travel: Allowed = 100 Actual = 45' 1" Travel Distance: Allowed = 300 Actual = 65' 1" Fourth Floor Common Path of Travel: Allowed = 100 Actual = 31' 9" Travel Distance: Allowed = 300 Actual = 50' 4"	Third Floor Water Closets Required = 3 Provided = 3 Water Fountain Required = 1 Provided = 1 Fourth Floor Water Closets Required = 2 Provided = 3 Water Fountain Required = 1 Provided = 1	City of Savannah International Building Code : 2018 Edition Life Safety Code : Life Safety Code, NFPA, 101 Building is equipped with automatic sprinkler system	ALV MANUAL ALARM SYSTEM EMERGENCY LIGHTING EXIT DETECTION SYSTEM

McKenzie Kaeser
mkaeser20@student.scd.edu

Project :
Array Behavioral Care
Project Location :
240 West Broughton St,
Savannah Georgia, 31401

Studio 3


Life Safety Plan

Project Number	Project Number
Date	Issue Date
Drawn By	Author
Checked By	Checker



G101

Scale 1/8" = 1'-0"

2/25/2021 7:46:55 PM

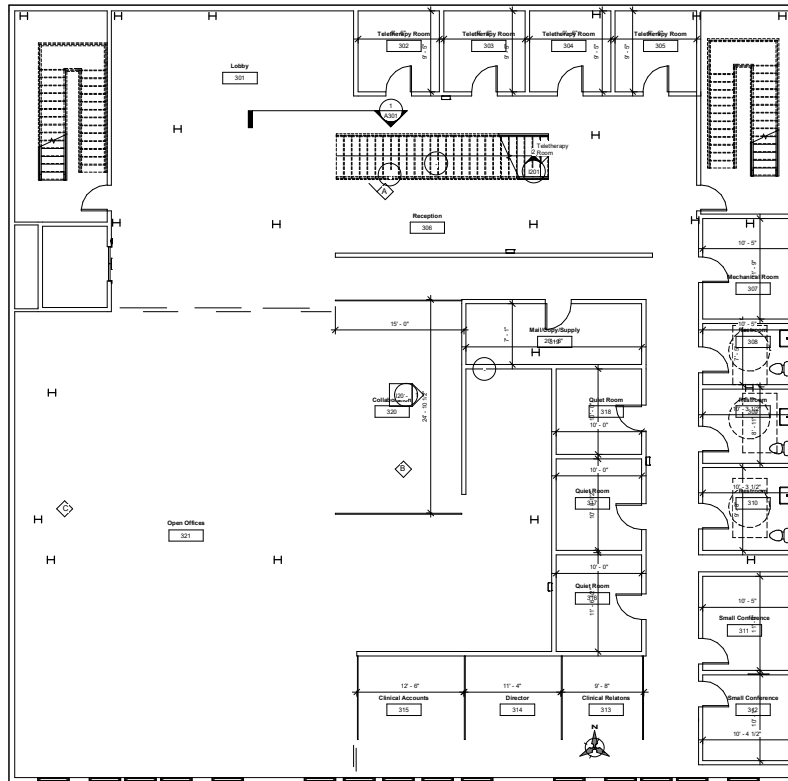

○ Floor above third floor
3/16" = 1'-0"

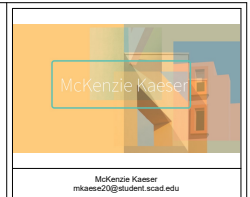 

Project :
Array Behavioral Care
Project Location :
240 West Broughton St,
Savannah Georgia, 31401




Studio 3


Floor Plan Third
Floor

Project Number	Project Number
Date	Issue Date
Drawn By	Author
Checked By	Checker
A101	
Scale	3/16" = 1'-0"

2/25/2021 7:30:08 PM

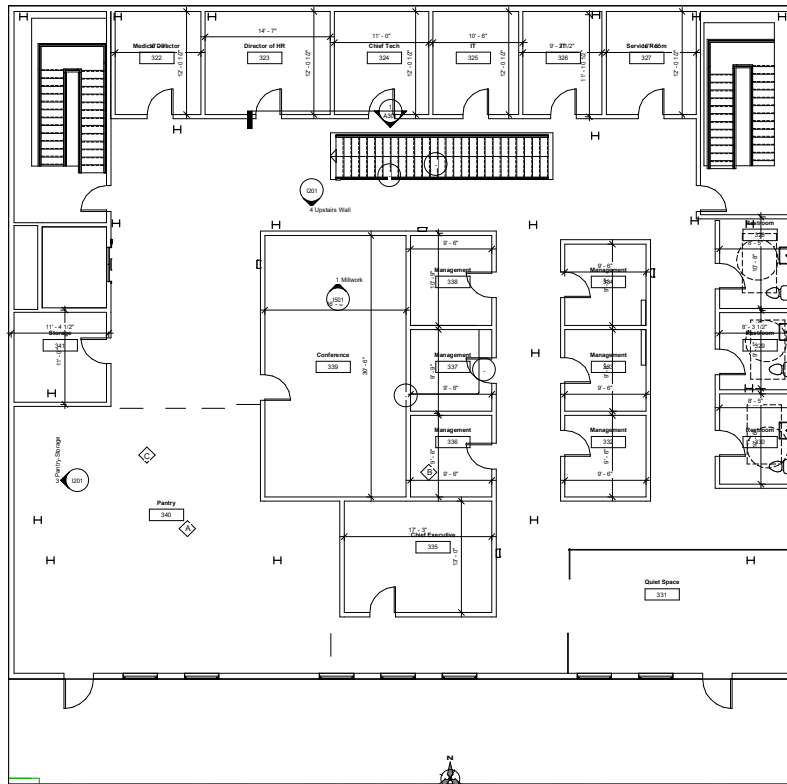

⊙ Floor plan fourth floor
3/16" = 1'-0"

 

McKenzie Kaeser
mkaes20@student.scad.edu


Project :
Array Behavioral Care
Project Location :
240 West Broughton St,
Savannah Georgia, 31401

Studio 3


Floor Plan Fourth Floor

Project Number	Project Number
Date	Issue Date
Drawn By	Author
Checked By	Checker
A102	
Scale	3/16" = 1'-0"

2/25/2021 7:20:48 PM

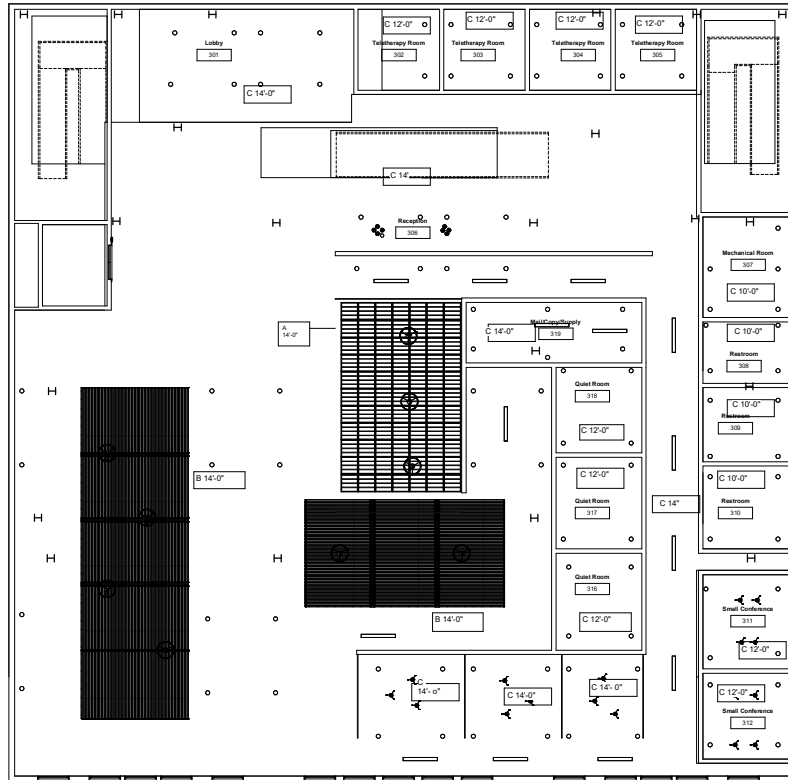

TAG	Manufacturer	Type	Notes
A	Armstrong	Wood Ceiling	A decorative, solid wood ceiling that is 100% accessible
B	Armstrong	Planks	acoustical
C	Armstrong	Seamless	Acoustic

 

Project :
Array Behavioral Care
Project Location :
240 West Broughton St,
Savannah Georgia, 31401



Studio 3

RCP (third floor)

Project Number _____ Project Number _____

Date _____ Issue Date _____


Drawn By _____ Author _____

Checked By _____ Checker _____


A103

Scale 3/16" = 1'-0"

2/25/2021 7:26:38 PM

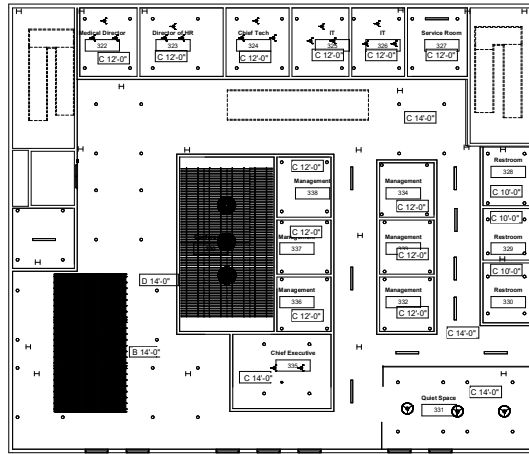

Level 2
1/8" = 1'-0"

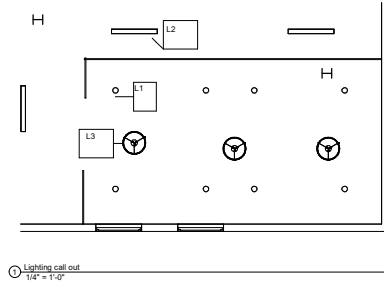

Legend	
	Recessed L1
	Recessed L2
	Pendant L3
	Pendant L4
	Pendant L5
	Suspension L6


				Tag	Manufacturer	Model	Bulb Type	Lumen	Wattage
Tag	Manufacturer	Type	Notes	L1	Finite	4" Round	LED	700	15
B	Armstrong	Planks	Acoustical	L2	H.E. Williams	1x4	LED	1000	15
				L3	Tech Lighting	Flama 24	LED	3000	51.7
C	Armstrong	Seamless	Acoustic	L4	Tech Lighting	Minda Pendant	LED	1000	9
				L5	Tech lighting	Orbal Pyramid	LED	3000	5
D	Armstrong	Blades	Vertical Panels	L6	Tech Lighting	Syma Grande	LED	500	17



Project :
Array Behavioral Care
Project Location :
240 West Broughton St,
Savannah Georgia, 31401



Studio 3	
RCP (fourth floor)	
Project Number	Project Number
Date	Issue Date
Drawn By	Author
Checked By	Checker
A104	
Scale	As indicated

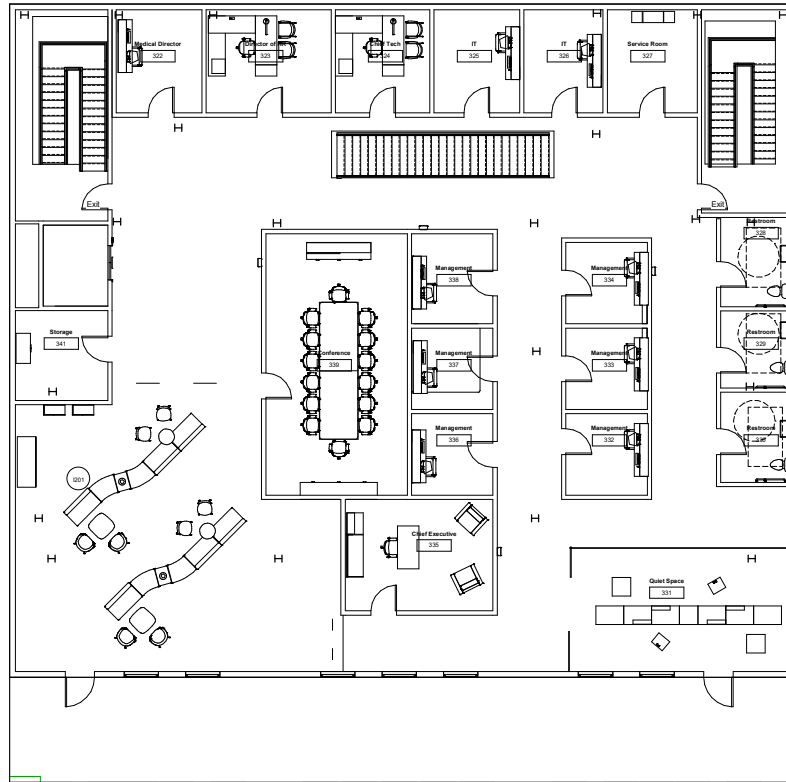

McKenzie-Kaesser
mkaessc00@student.scad.edu

Project :
Array Behavioral Care
Project Location :
240 West Broughton St,
Savannah Georgia, 31401




Studio 3

Furniture Plan
(fourth floor)

Project Number	Project Number
Date	Issue Date
Drawn By	Author
Checked By	Checker
1102	
Scale	3/16" = 1'-0"

2/25/2021 7:40:12 PM

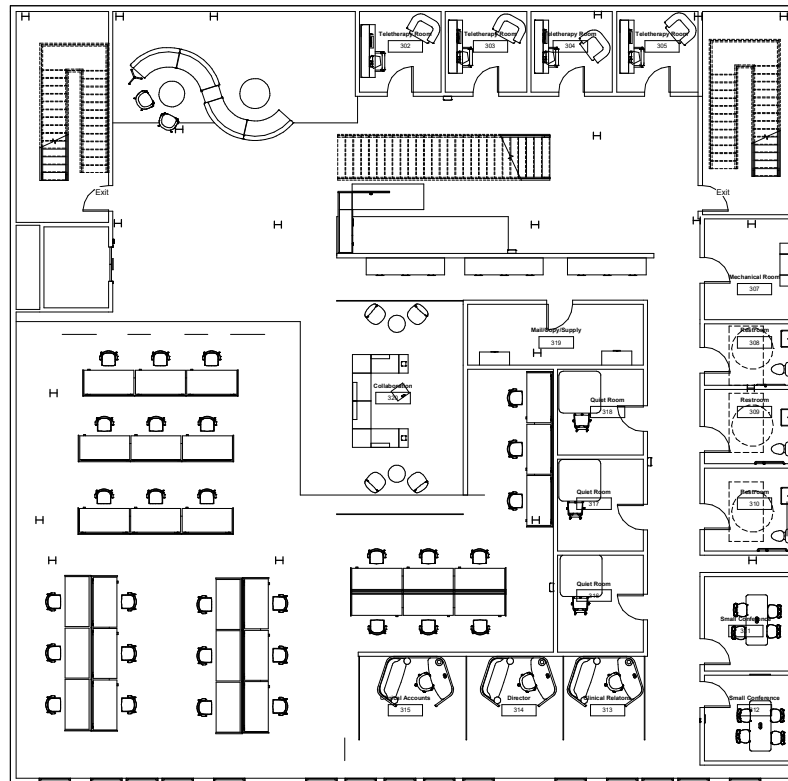

① Third Floor Furniture Plan
3/16" = 1'-0"



McKenzie Kaeser
mkaes00@student.scd.edu

Project :
Array Behavioral Care
Project Location :
240 West Broughton St,
Savannah Georgia, 31401




Studio 3

Furniture Plan (third
floor)

Project Number	Project Number
Date	Issue Date
Drawn By	Author
Checked By	Checker
I101	
Scale	3/16" = 1'-0"

2/25/2021 7:50:48 PM

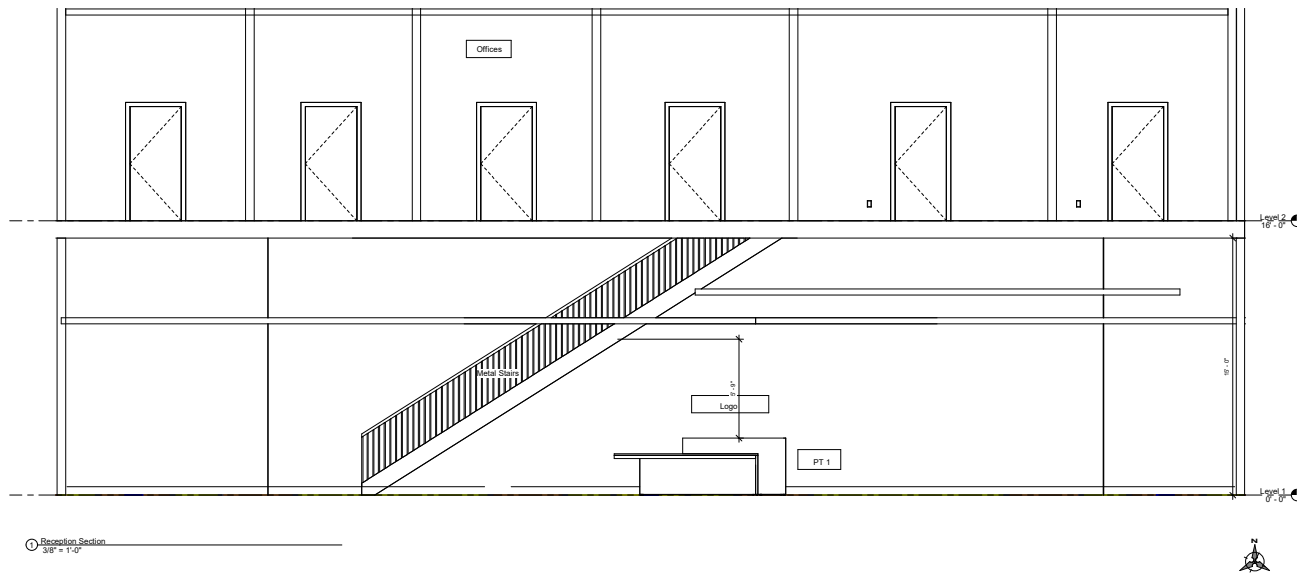

Project :
Array Behavioral Care
Project Location :
240 West Broughton St,
Savannah Georgia, 31401



Studio 3

Building Section

Project Number	Project Number
Date	Issue Date
Drawn By	Author
Checked By	Checker
A301	
Scale	3/8" = 1'-0"

2/25/2021 7:37:27 PM

McKenzie Kaeser

McKenzie Kaeser
mkaes00@student.scad.edu

Project :
Array Behavioral Care
Project Location :
240 West Broughton St,
Savannah Georgia, 31401

array

Studio 3

Floor Finish Plan
(third floor)

Project Number

Project Number

Date

Issue Date

Drawn By

Author

Checked By


Checker

I103

Scale


1/8" = 1'-0"

2/25/2021 7:42:00 PM

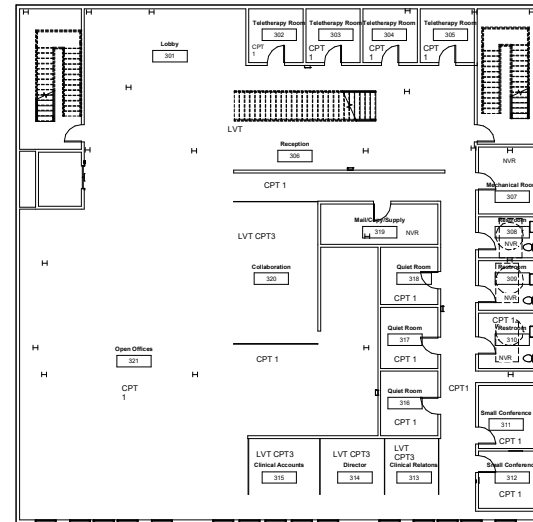

Finish plan third floor
1/8" = 1'-0"

TAG	Manufacturer	Name	Color	Size	Surface	Installation Instructions	NOTES
CPT 1	Shaw Contract	Clearing Tile	Reservoir 71485	9 in x 36 in	Floor		Backing: EcoWorl® Tile Fiber: eco solution dB nylon Tufted Weight: 30 oz/yd² 678.1 g/m² Area per carton: 45.8' x 4.18 m² Warranty(s): Lifetime Commercial Limited Warranty
LVT	Shaw Contract	EON	R/R 12114	20 in x 20 in	Floor		Construction Heavy Commercial Luxury Vinyl Tile Type: LVT Overall thickness: 5 mm Wear Layer Thickness: 22mil(0.022 in) 0.56 Installation: Direct Glue, Floating Or Perimeter Glue Warranty(s): 15 Year Commercial Limited Warranty
CPT 2	Shaw Contract	Archway	Sketch 70675	12ft	Floor	Direct glue, Double Glue, Stretch In	Backing: Ultraloc® Fiber: eco solution dB nylon Tufted Weight: 51 oz/yd² 1729.2 gm² Warranty(s): Lifetime Commercial Limited Warranty
NVR	Mannington Commercial	Legato Liquid Linoleum	GR346	73 Sq Ft	Floor	Homogenous Poured In Place	Legato Liquid Linoleum can be installed across many segments that require the benefits of infection control, slip resistance, and sound dampening – trails that go above and beyond that of a traditional linoleum thanks to its seamless installation and Quantum Guard Estell® technology.
CPT 3	Shaw Contract	Dots	Transform 76735	12 Ft	Floor	Direct Glue, Double Glue, Stretch In	Backing: Ultraloc® Fiber: eco solution dB nylon Tufted Weight: 36 oz/yd² 1200.6 g/m² Warranty(s): Lifetime Commercial Limited Warranty

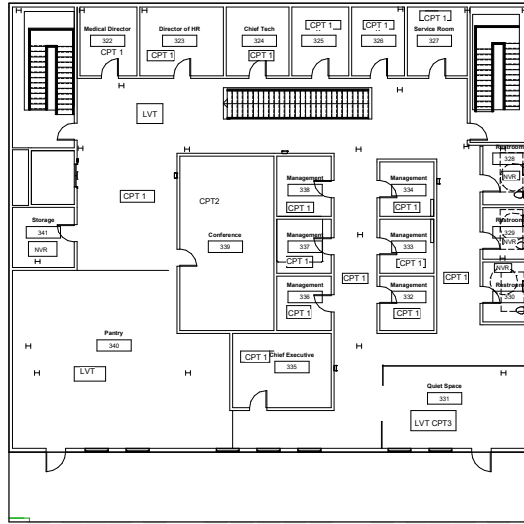

TAG	Manufacturer	Name	Color	Size	Surface	Installation Instructions	NOTES
CPT 1	Shaw Contract	Cleaving Tile	Reservoir 71485	9 in x 36 in	Floor		Backing: EcoWorx® Tile Fiber: eco solution q8 nylon Tufted Weight: 20 oz/yd² (678.1 g/m²) Area per carton: 48 ft² (4.4 m²) Warranty(s): Lifetime Commercial Limited Warranty
LVT	Shaw Contract	EON	Rft 12114	20 in x 20 in	Floor		Construction Heavy Commercial Luxury Vinyl Tile Type: LVT Overall Thickness: 5 mm Wear Layer Thickness: 22mil(0.022 in) 0.56 Installation: Direct Glue, Floating Or Perimeter Glue Warranty(s): 15 Year Commercial Limited Warranty
CPT 2	Shaw Contract	Archway	Sketch 70675	12ft	Floor	Direct glue, Double Glue, Stretch In	Backing: Ultralo® Fiber: eco solution Q8 nylon Tufted Weight: 51 oz/yd² 1729.2 g/m² Warranty(s): Lifetime Commercial Limited Warranty
NVR	Mannington Commercial	Legato Liquid Linoleum	GR346	73 Sq Ft	Floor	Homogeneous Poured In Place	Legato Liquid Linoleum can be installed across many segments that require the benefits of infection control, slip resistance, and sound dampening – traits that go above and beyond that of a traditional linoleum thanks to its seamless installation and Quantum Guard Elite® technology.
CPT 3	Shaw Contract	Dots	Transform 76735	12 Ft	Floor	Direct Glue, Double Glue, Stretch In	Backing: Ultralo® Fiber: eco solution Q8 nylon Tufted Weight: 38 oz/yd² 1220.6 g/m² Warranty(s): Lifetime Commercial Limited Warranty

McKenzie Kaeser
mkaes00@student.scd.edu

Project :
 Array Behavioral Care
 Project Location :
 240 West Broughton St,
 Savannah Georgia, 31401

Studio 3


Floor Finish Plan
 (fourth floor)

Project Number	Project Number
Date	Issue Date
Drawn By	Author
Checked By	Checker

1104

Scale 1/8" = 1'-0"

2/25/2021 7:42:25 PM

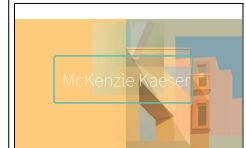

McKenzie Kaeser
mkaesc20@student1.scad.edu

Project :
Array Behavioral Care
Project Location :
240 West Broughton St,
Savannah Georgia, 31401




Studio 3


Large Scale Finish
Plan

Project Number	Project Number
Date	Issue Date
Drawn By	Author
Checked By	Checker
1401	
Scale	3/8" = 1'-0"

2/25/2021 7:45:34 PM

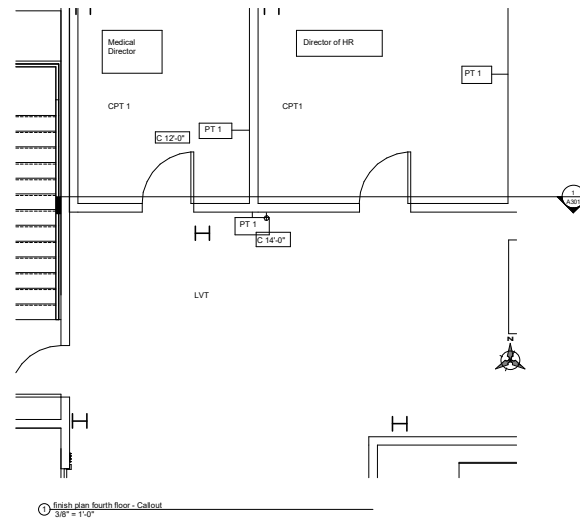

TAG	Manufacturer	Name	Color	Size	Surface	Installation Instructions	NOTES
CPT 1	Shaw Contract	Clearing Tile	Reservoir 71485	9 in x 36 in	Floor		Backing: EcoWork® Tile Fiber: iso solution 69 nylon Tuff Weight: 20 oz/yd² 678.1 g/m² Area per carton: 45 ft² 4.18 m² Warranty(s): Lifetime Commercial Limited Warranty
LVT	Shaw Contract	EON	RIR 12114	20 in x 20 in	Floor		Construction Heavy Commercial Luxury Vinyl Tile Type: LVT Overall Thickness: 5 mm Wear Layer Thickness: 22mil(0.022 in) 0.56 Installation: Direct Glue, Floating Or Perimeter Glue Warranty(s): 15 Year Commercial Limited Warranty
PT 1	Sherman Miller	SW 7005	Pure White	NA	Walls	Eggshell	Color Collections Trendssetter, Dreamer, Pottery Barn - Fall/Winter 2020, Living Well - Unwind, Timeless White, 2500 Play, Acute Care Cool Foundations, ABC's and 123's, Inbe Tween's, Teen Space, 2021 Sanctuary

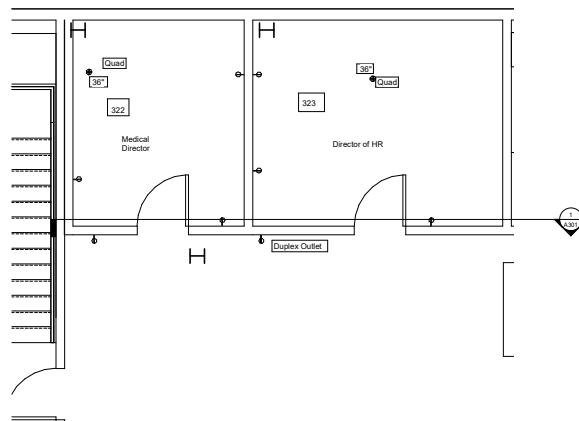

1/8" = 1'-0"



Legend



Duplex Outlet



Quad Outlet

McKenzie Kaeser

McKenzie Kaeser
mkaeser20@student.scad.edu

Project :
Array Behavioral Care
Project Location :
240 West Broughton St,
Savannah Georgia, 31401



Studio 3

Large Scale Power
and Data Plan

Project Number	Project Number
Date	Issue Date
Drawn By	Author
Checked By	Checker
1402	
Scale	3/8" = 1'-0"

2/25/2021 7:46:45 PM




Project :
Array Behavioral Care
Project Location :
240 West Broughton St,
Savannah Georgia, 31401




Studio 3
Wall Elevations

Project Number	Project Number
Date	Issue Date
Drawn By	Author
Checked By	Checker
I201	
Scale	As indicated

2/25/2021 7:44:52 PM

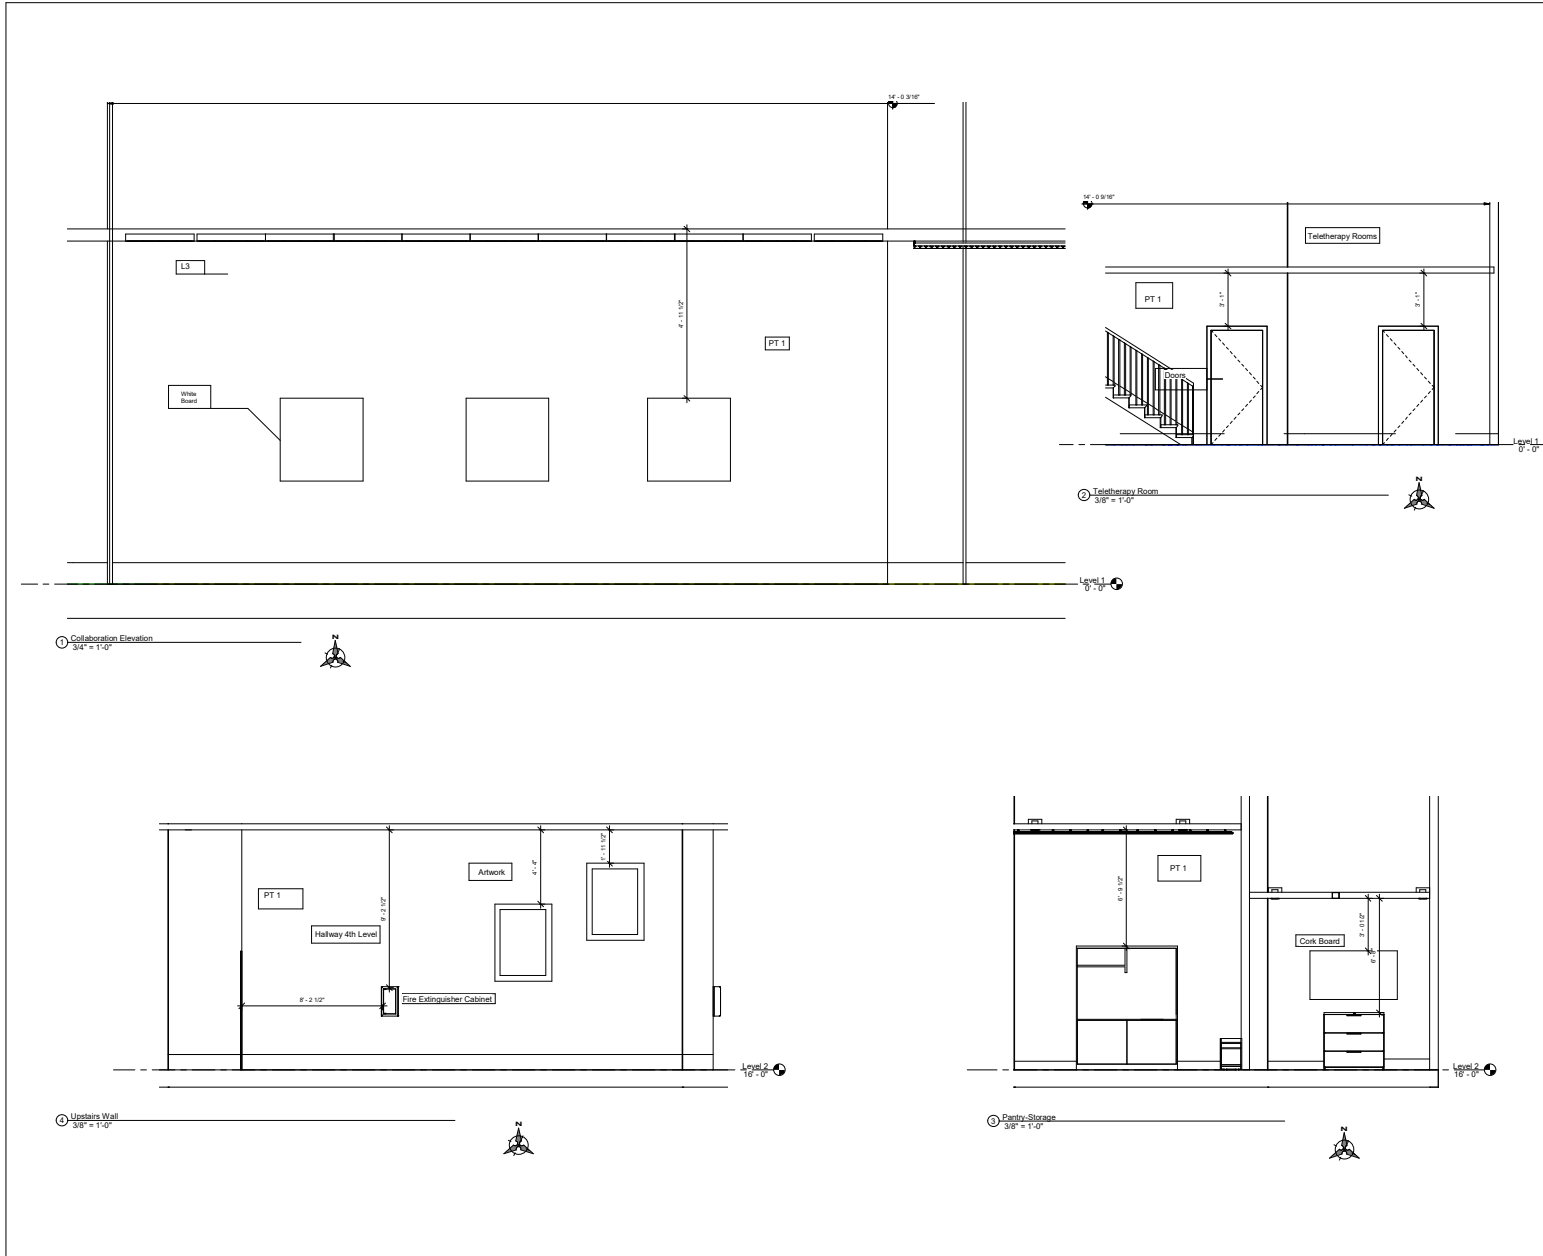

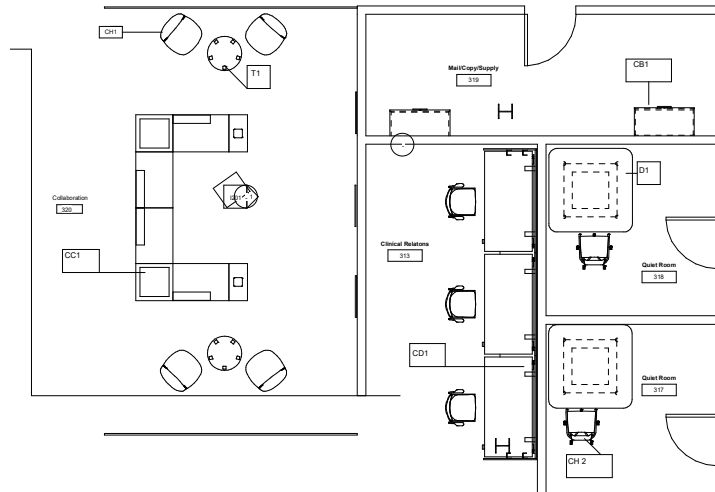

① Third Floor Furniture Plan - Callout 1
3/8" = 1'-0"



Tag	Manufacturer	Name	Color	Fabric	Size	Quantity	Notes
CH1	Teknion	Seating Four	Neutral	Upholstery	2'	4	Collaboration
CH2	Teknion	Seated Tilt	Gray	Leather	2'	3	Quiet
CC1	Teknion	SO Seal Bench	White	Upholstery	10'	1	Collaboration
CD 1	Teknion	Navigate HAB	Gray	Metal	18'	10	Open
D1	Teknion	Square Workshop Table	Brown	Wood	4'	3	Quiet
CB 1	Teknion	Credenza	White	Wood	3' 4"	3	Mail
T1	Teknion	Cesto	Neutral	Wood	24"	2	Collaboration



McKenzie Kaeser
mkaes20@student.scd.edu

Project :
Array Behavioral Care
Project Location :
240 West Broughton St,
Savannah Georgia, 31401




Studio 3

Large Scale
Furniture Plan with
specifications

Project Number	Project Number
Date	Issue Date
Drawn By	Author
Checked By	Checker
1403	
Scale	3/8" = 1'-0"

2/25/2021 7:47:40 PM

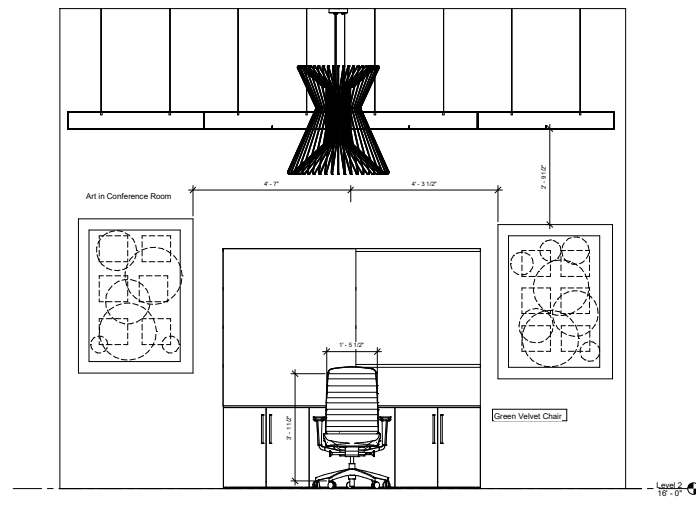

① Milwork
3/4" = 1'-0"

McKenzie Kaeser
mkaes20@student.scad.edu

Project :
Array Behavioral Care
Project Location :
240 West Broughton St,
Savannah Georgia, 31401

Studio 3

Milwork Details

Project Number	Project Number
Date	Issue Date
Drawn By	Author
Checked By	Checker

I501

Scale	3/4" = 1'-0"
-------	--------------

2/25/2021 7:46:18 PM